
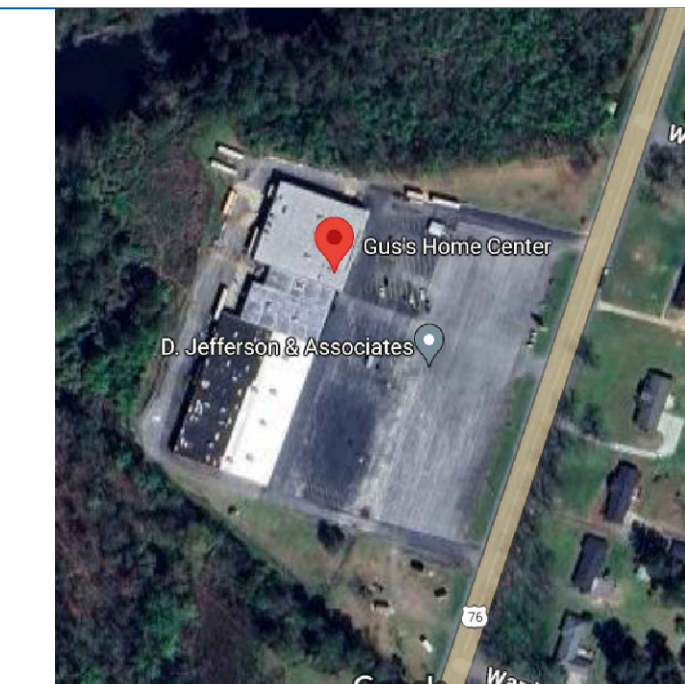



CoOperate Event Space

1305 ANDERSON STREET
BELTON, SC 29627

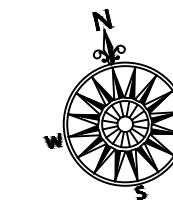


AERIAL VIEW OF SITE
SCALE: NTS

THE ARTS
SIMPSONVILLE, SC
(864)958-5000
designbythearts@gmail.com

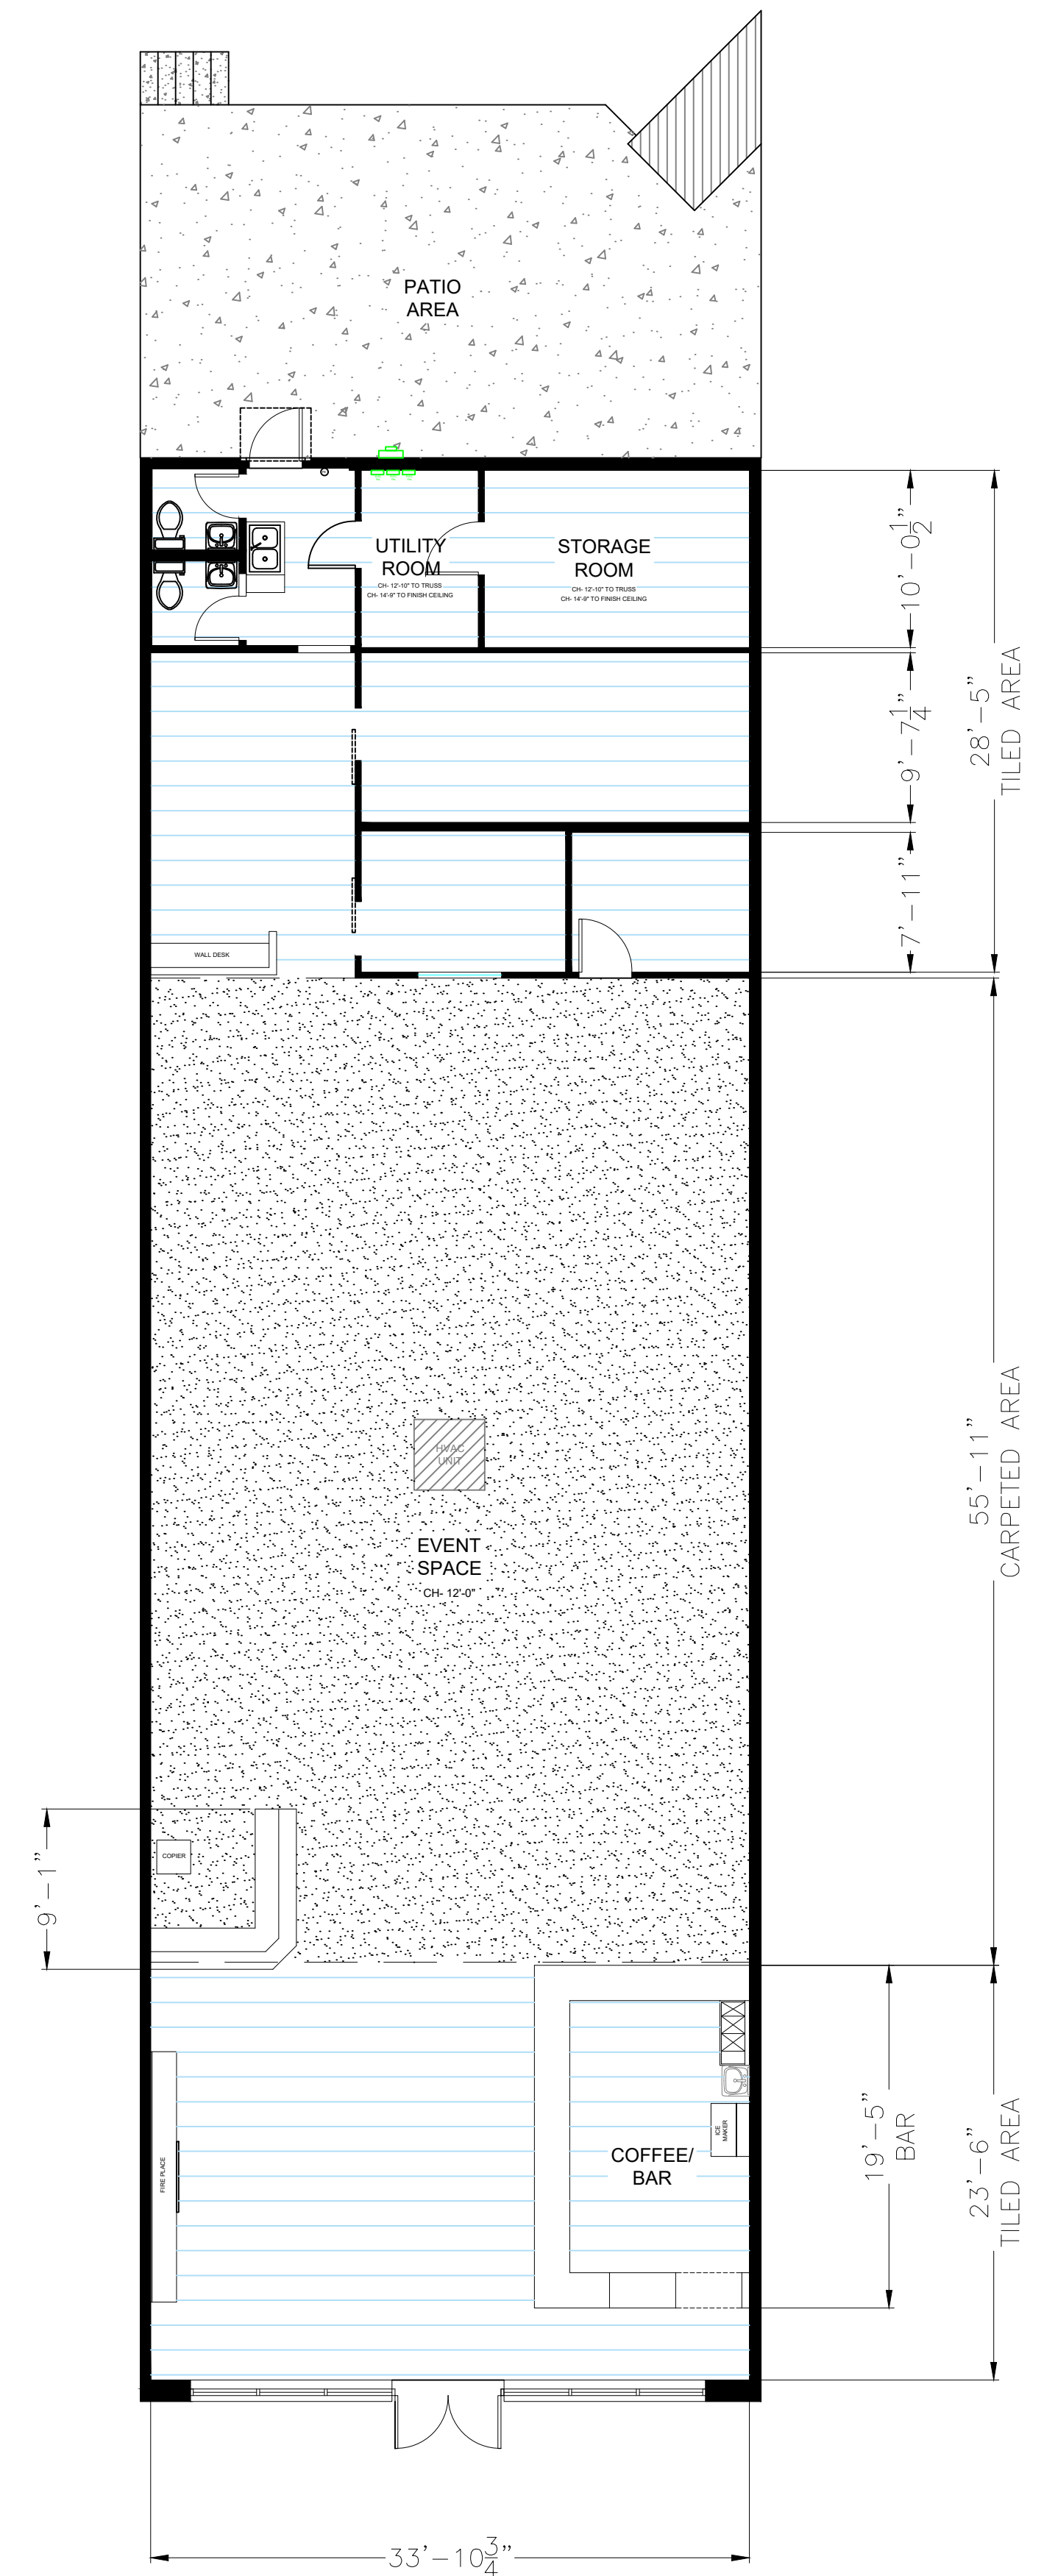


FLOOR PLAN

SCALE: 1/8"=1'-0"

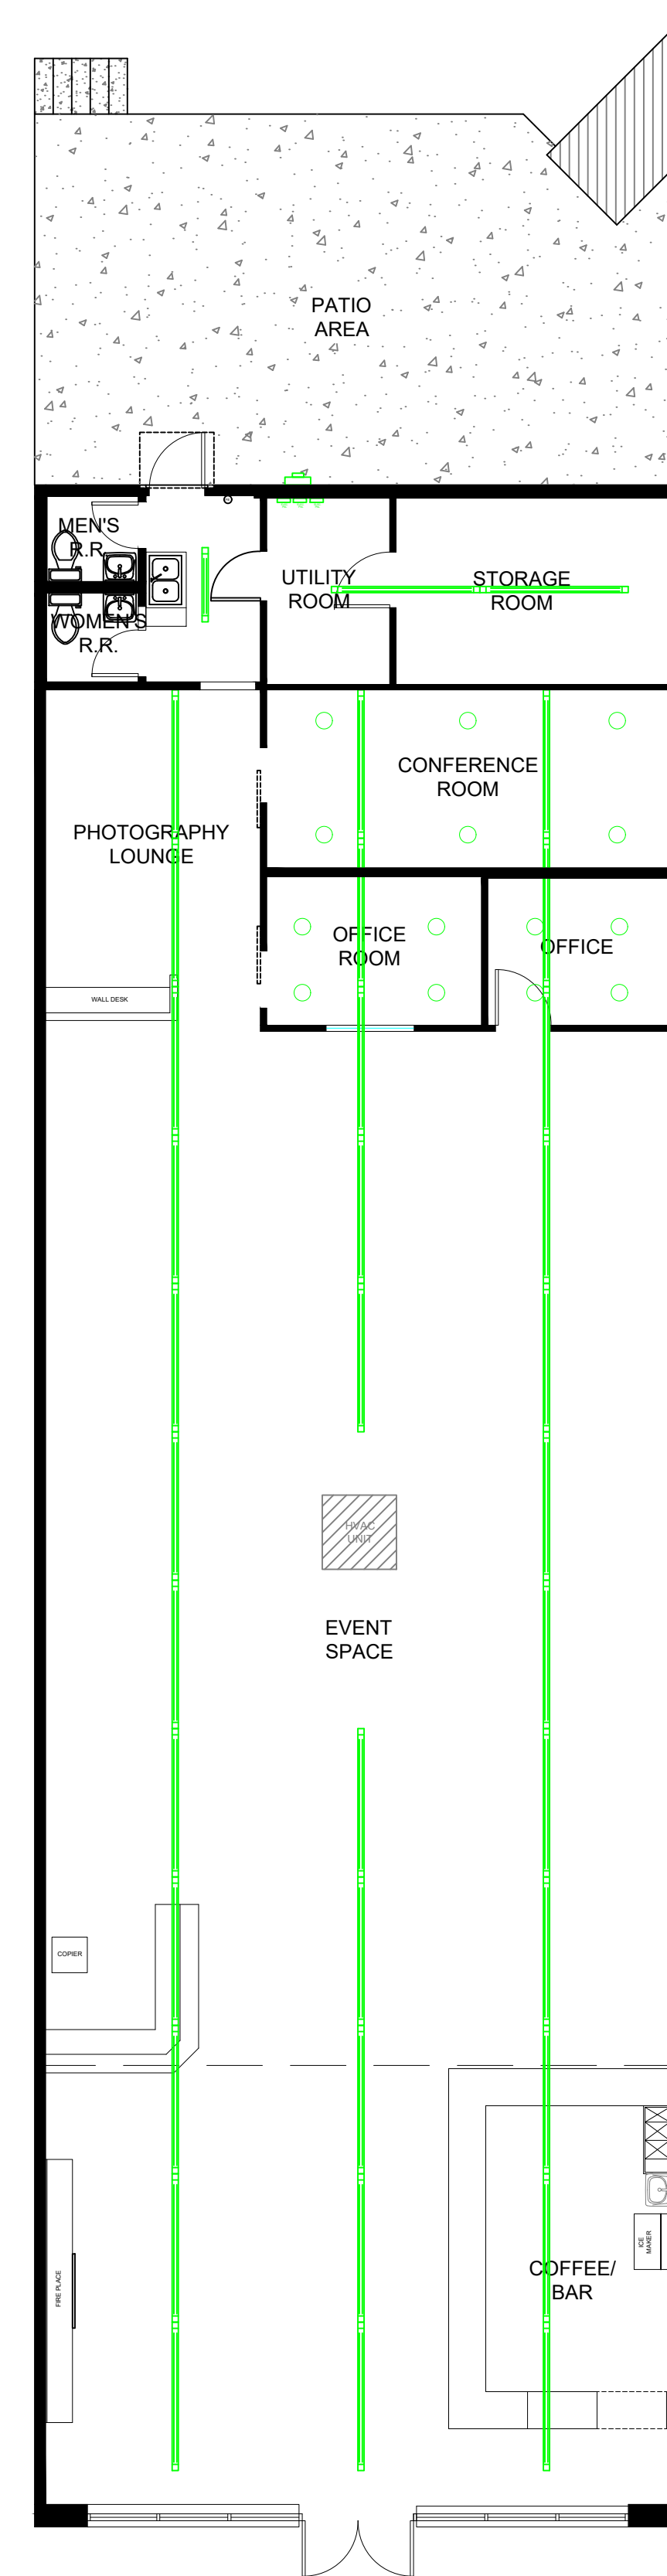


LIGHTING PLAN

SCALE: 1/8"=1'-0"

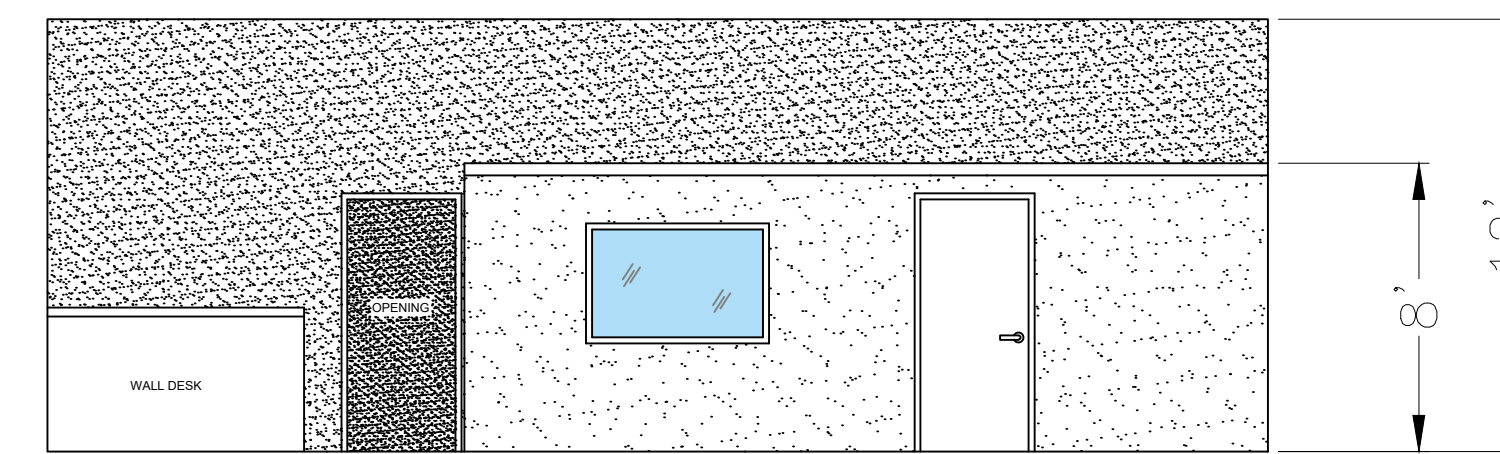

BACK WALL ELEVATION

SCALE: 3/16"=1'-0"

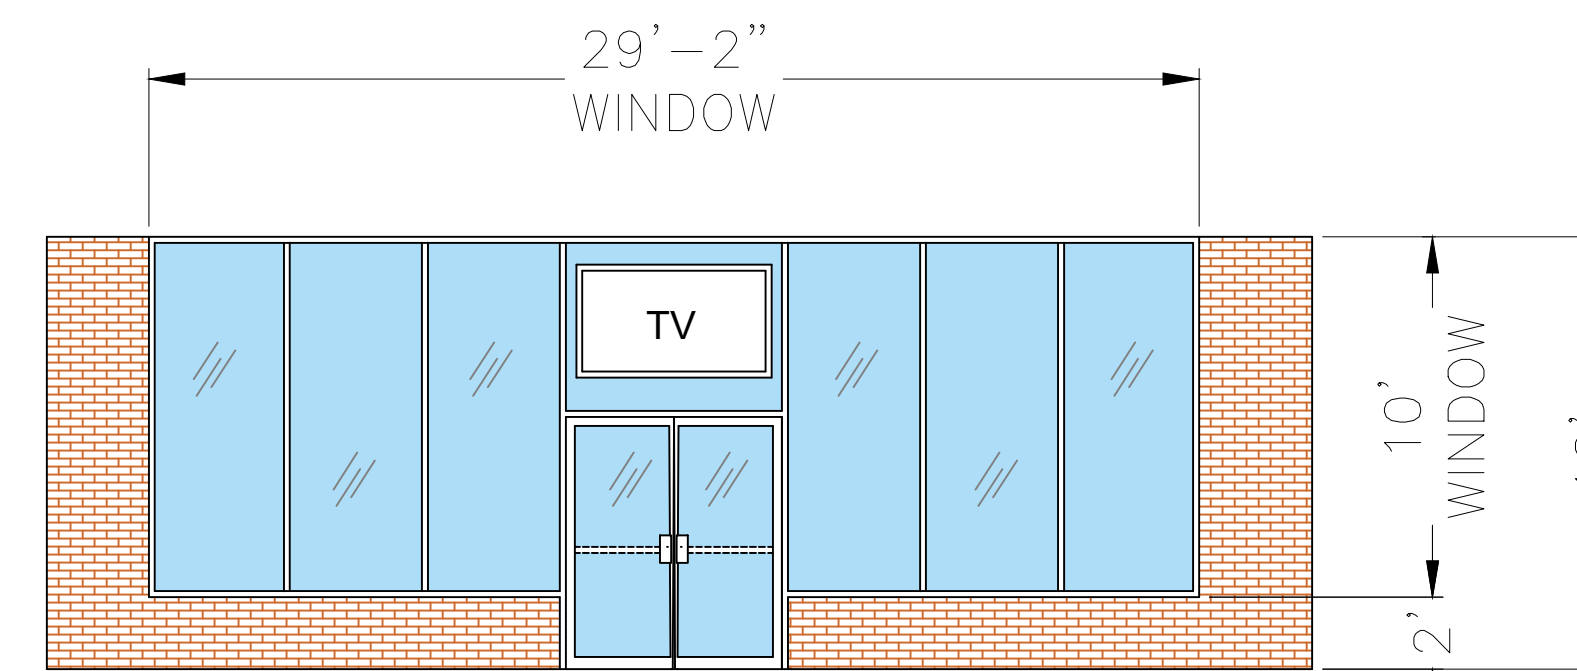

FRONT DOOR ELEVATION

SCALE: 3/16"=1'-0"

Notes:

REV:	DESCRIPTION:	BY:	DATE:

STATUS:

CoOperate Event Space
SHARED EVENT
SPACE
1024 ANDERSON STREET,
BELTON, SC 29627

SITE: 1024 ANDERSON STREET BELTON, SC 29627			
TITLE: EXISTING PLANS			
SCALE AT A1: AS NOTED	DATE: 6/2/2024	DRAWN: LCY	CHECKED: NA
DRAWING NO:	PAGE NUMBER 1	REVISION:	A